

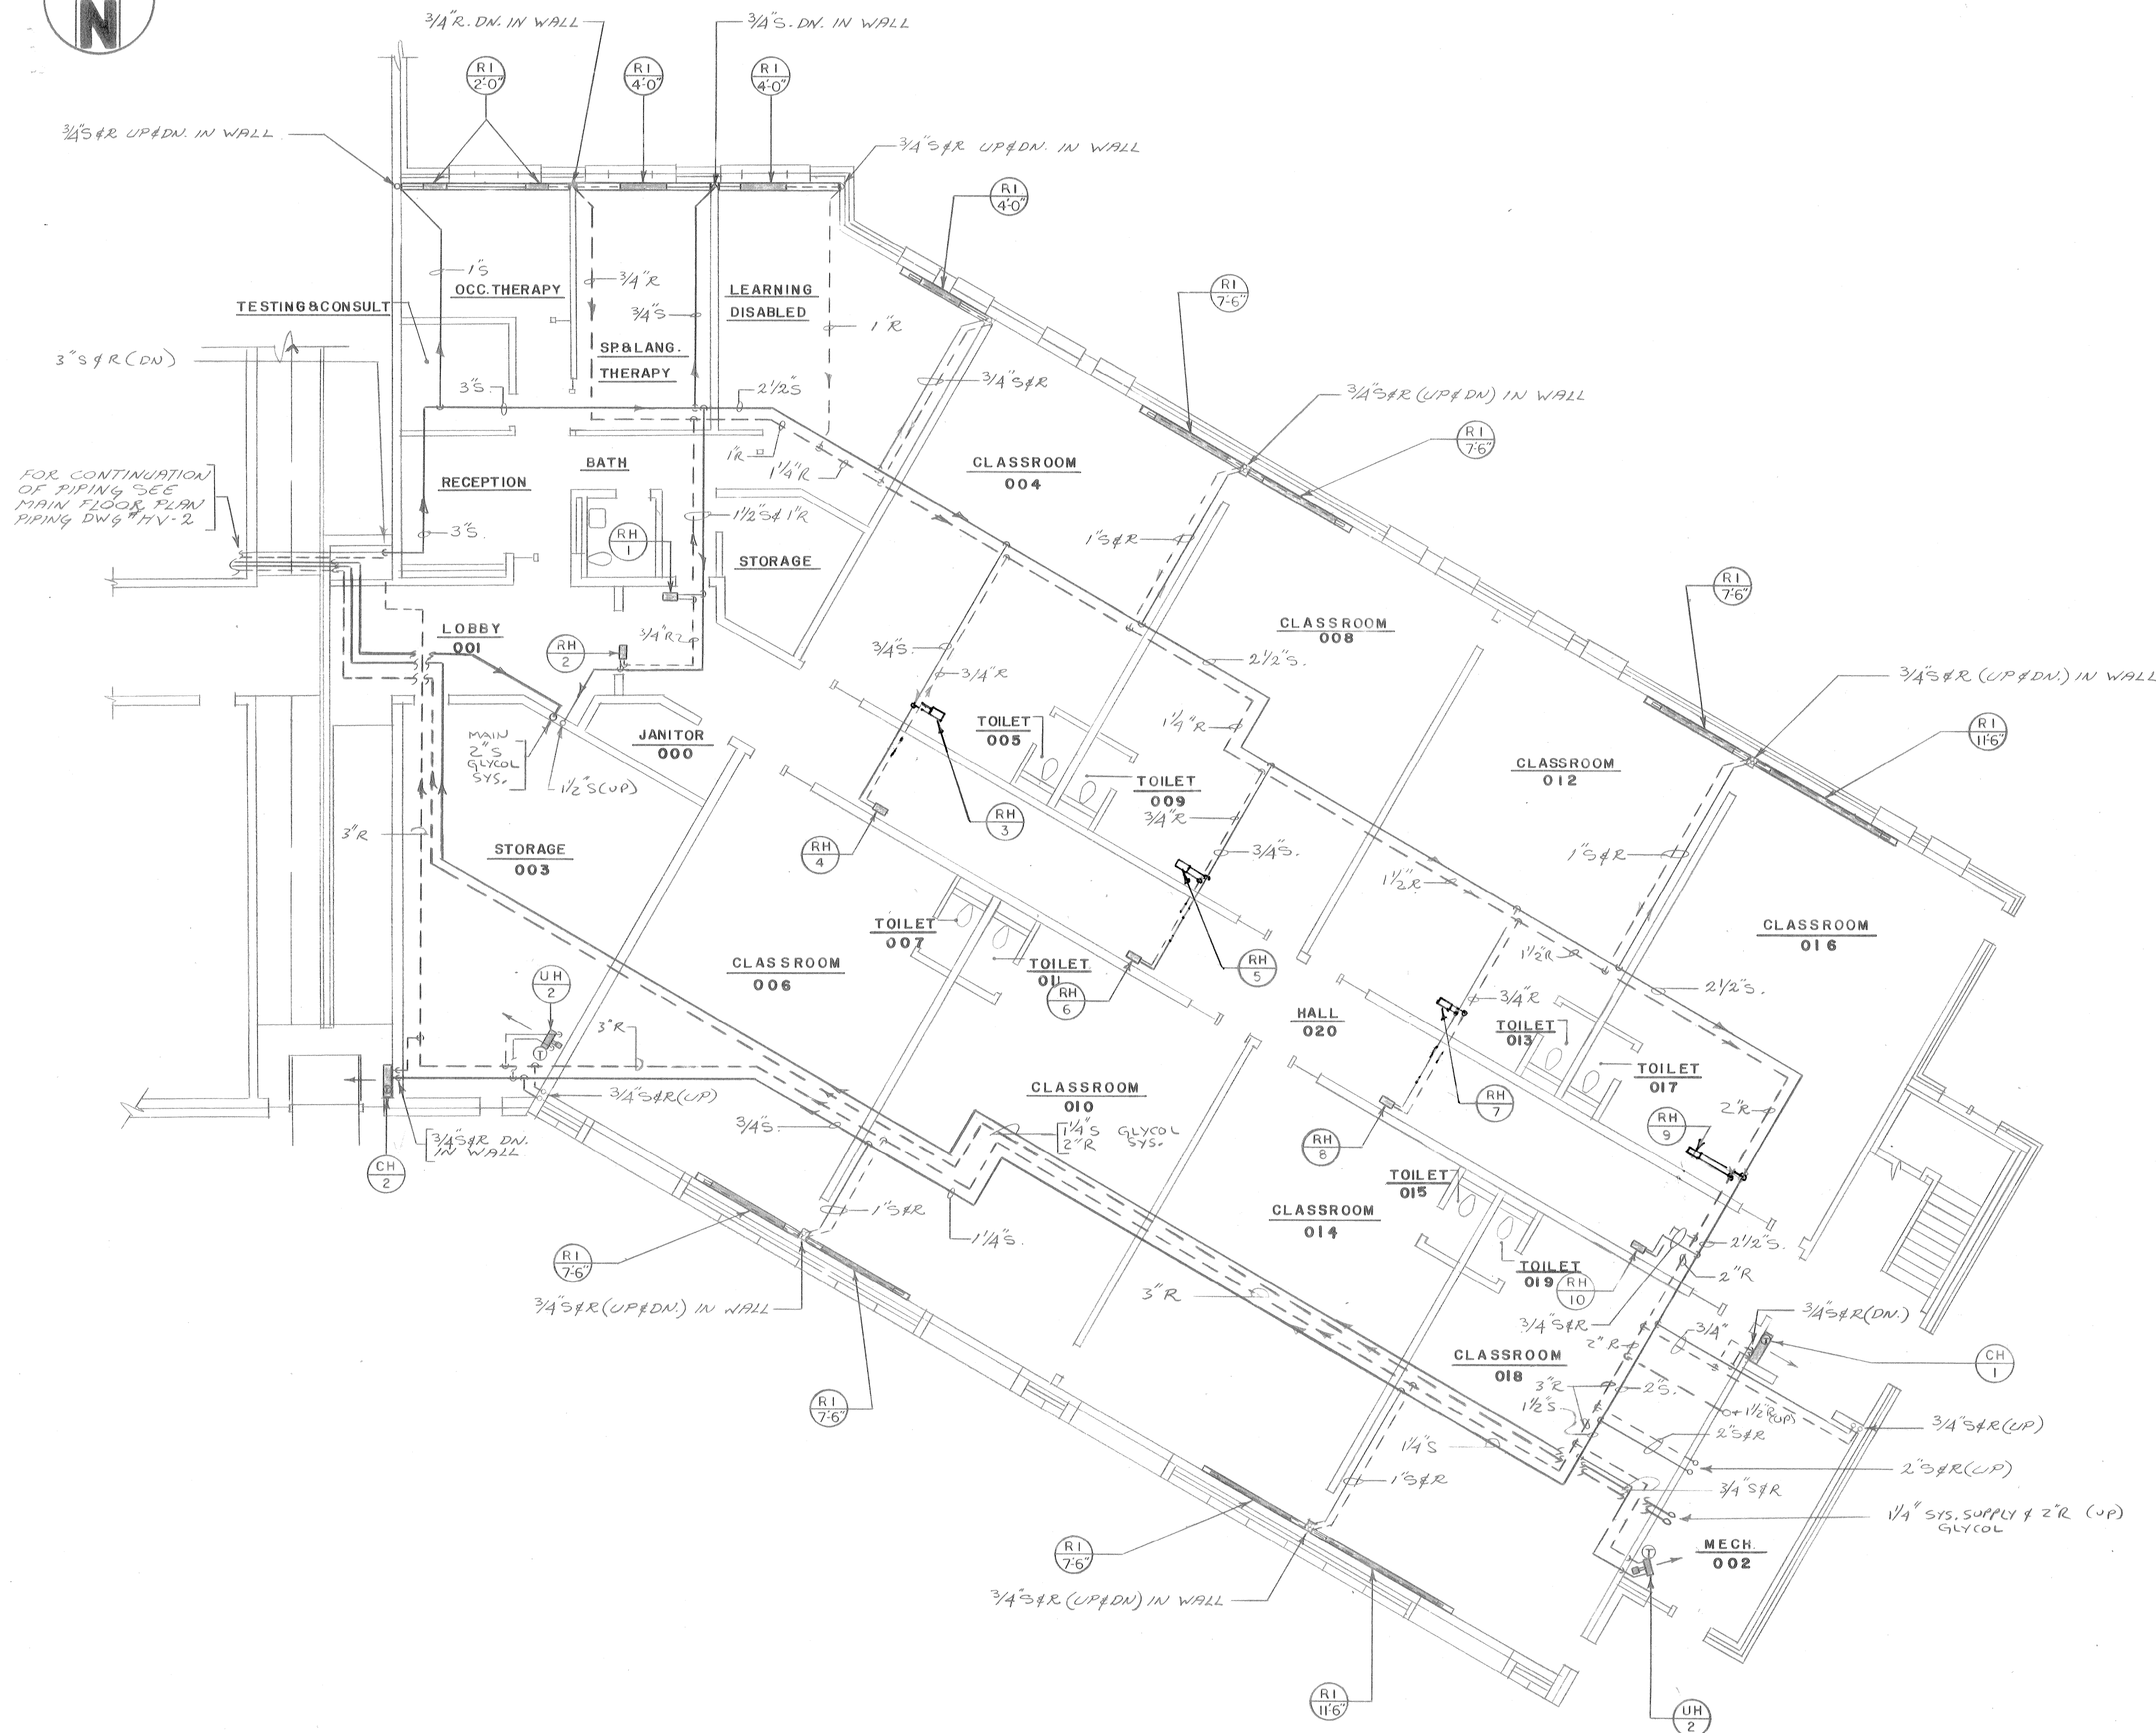
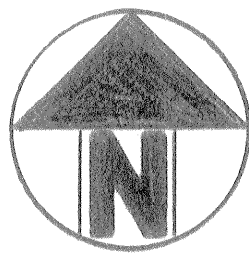


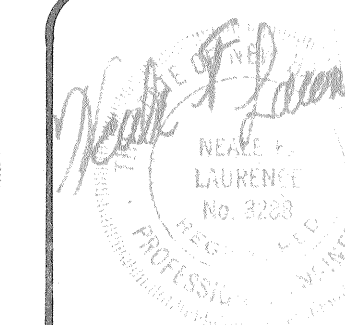

HEATING & VENTILATING GROUND FLOOR PLAN
SCALE 1/8" = 1'-0" (PIPING)

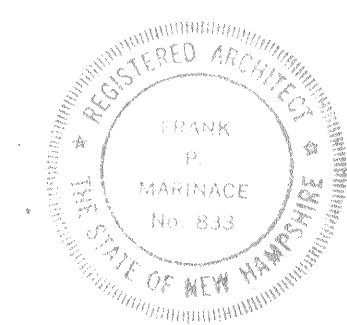

N.F. LAURENCE and ASSOCIATES, INC.
CONSULTING ENGINEERS
103 WEST MAIN STREET
NORTHBOROUGH, MASSACHUSETTS 01532

dwg. no.
HV-4

proj. 68
date 8/1
scale AS 1
by D.A.S.
rev. As-Built
10-27-8

HEATING & VENTILATING-GROUND FLOOR PLAN (PIPING)
NEW LONDON ELEMENTARY SCHOOL
LONDON, NEW HAMPSHIRE

FRANK P. MARINACE/ARCHITECT, P.A.
BOX 429 NEW HAMPTON, NEW HAMPSHIRE 03256
TELEPHONE (603) 744-5144