
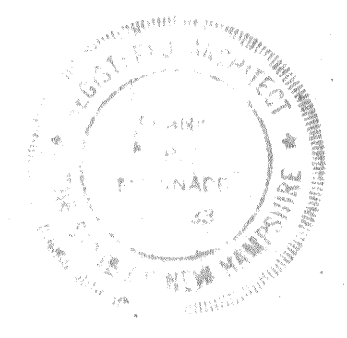


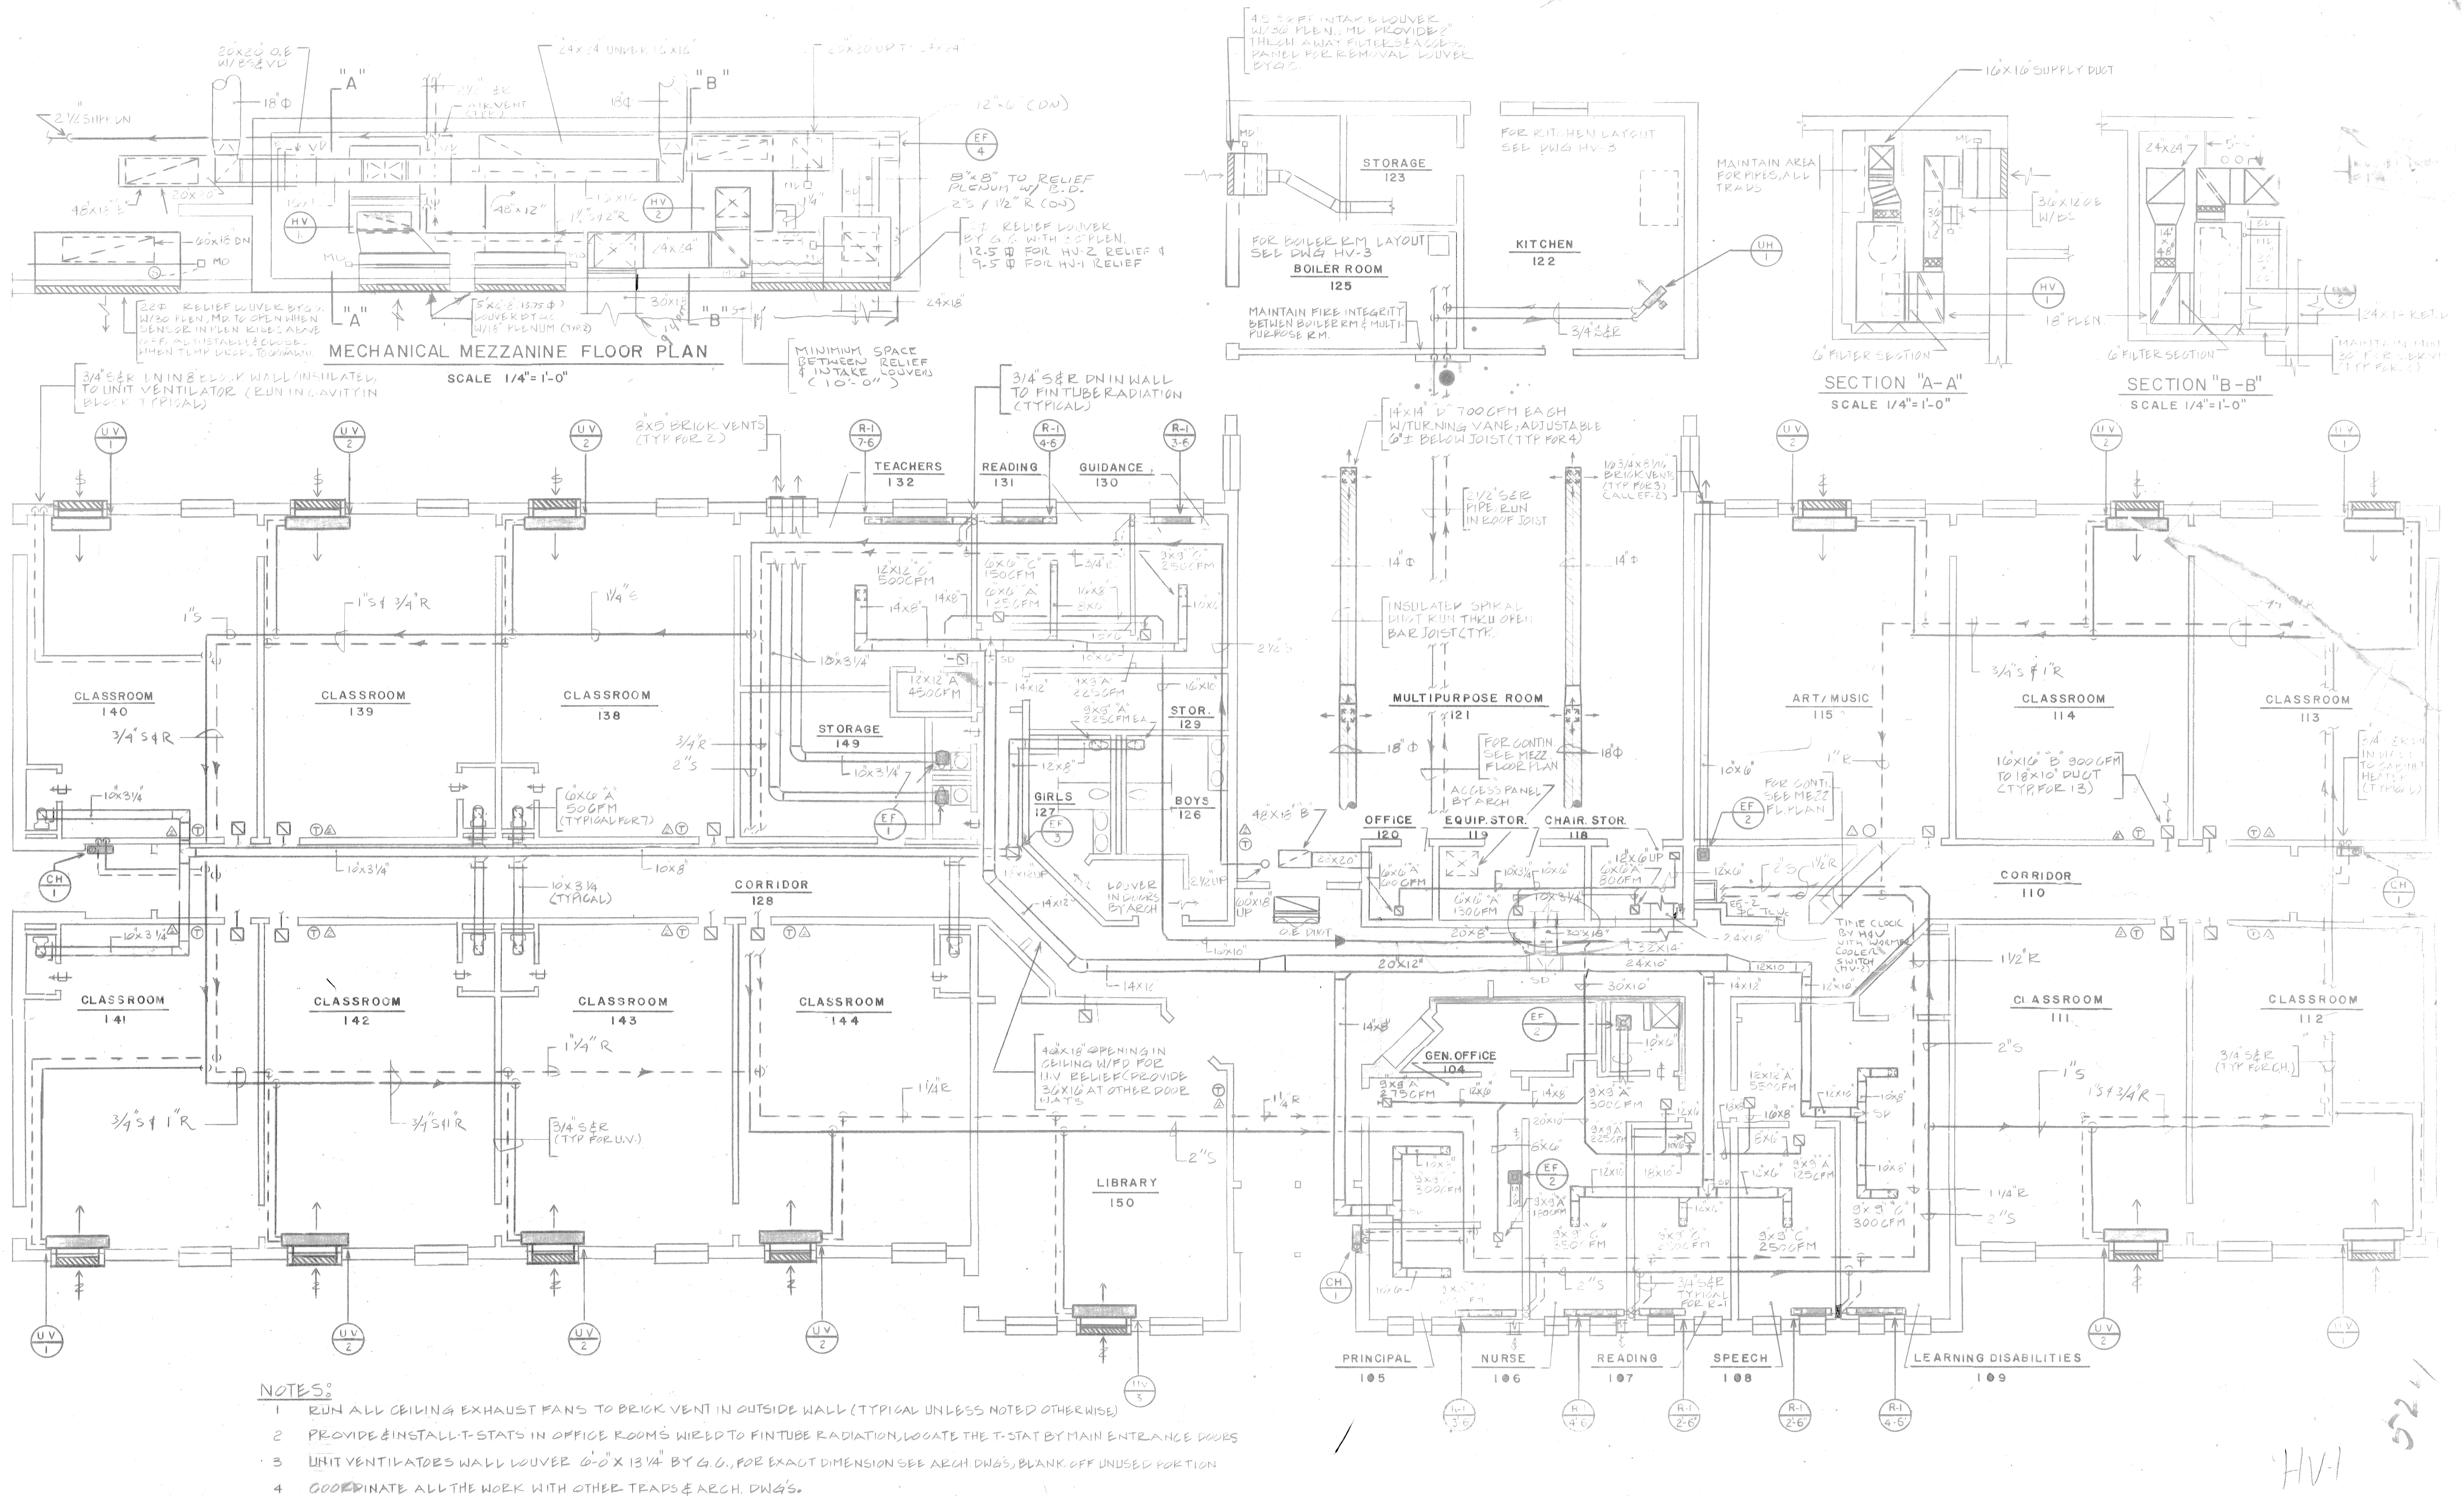

N.F. LAURENCE and ASSOCIATES, INC.
CONSULTING ENGINEERS
113 WEST MAIN STREET
NORTHBOROUGH, MASSACHUSETTS 01532

REV. J.J.A.
BY J.J.A.
DATE 8/15/86
SCALE AS NOTED
PROJ. 684

HEATING & VENTILATING FLOOR PLAN
BRADFORD ELEMENTARY SCHOOL
BRADFORD, NEW HAMPSHIRE

FRANK P MARINACE/ARCHITECT, P.A.
BOX 429 NEW HAMPTON, NEW HAMPSHIRE 03256 TELEPHONE (603) 765-1111